



 







FIRST FLOOR FLOOR PLAN, DORMITORY 3 BUILDING

 <div>Office of Engineering & Technical Services Philippine General Hospital University of the Philippines Taft Avenue, Ermita, Manila</div> 	PROJECT TITLE:	PREPARED BY:	END - USER:	ENDORSED BY:	RECOMMENDING APPROVAL:	APPROVED:	SHEET NO.
	PROPOSED RENOVATION OF TOILETS AND CONSTRUCTION OF SEPTIC TANK LOCATION: Ground Floor, Dormitory 3 Building, UP-PGH Compound, Taft Avenue, Ermita, Manila	 ENGR. MUEL Q. DEL MONTE JR. Engineer II, PMU	 VILMA Q. VIESCA Dormitory Manager III	 ENGR. LORNA G. POUNTAIN Head, Project Management Unit	 MARIA TERESA JULIETA U. BENEDICTO, MD Deputy Director for Administration	 GERARDO D. LEGASPI, MD Director, UP-PGH	<div>1</div> <div>7</div>
	CADD BY: Rhyan Jay B. Galenzoga	052920					

JUL 23 2020



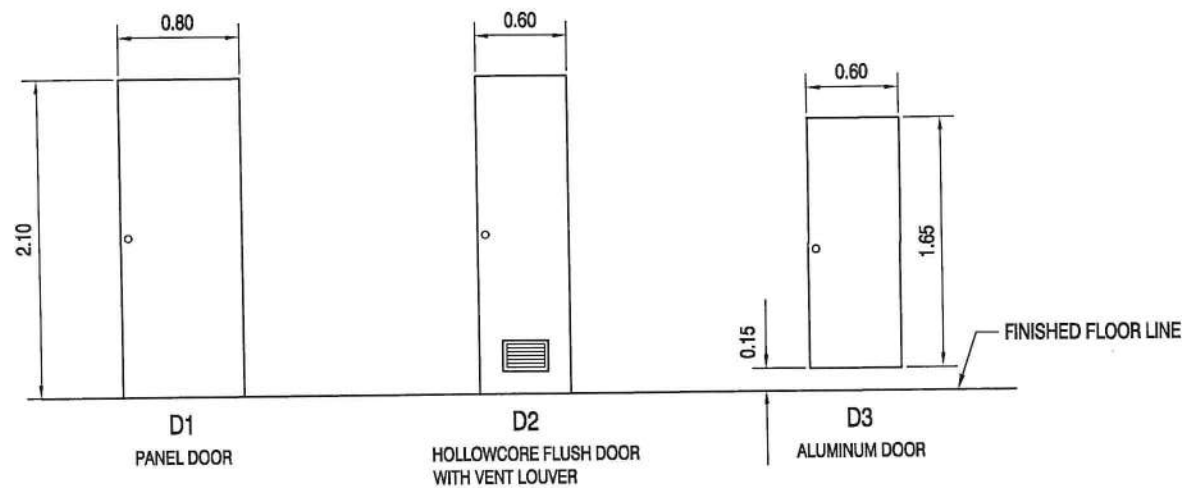SCHEDULE OF DOORS
SCALE 1:50 M.

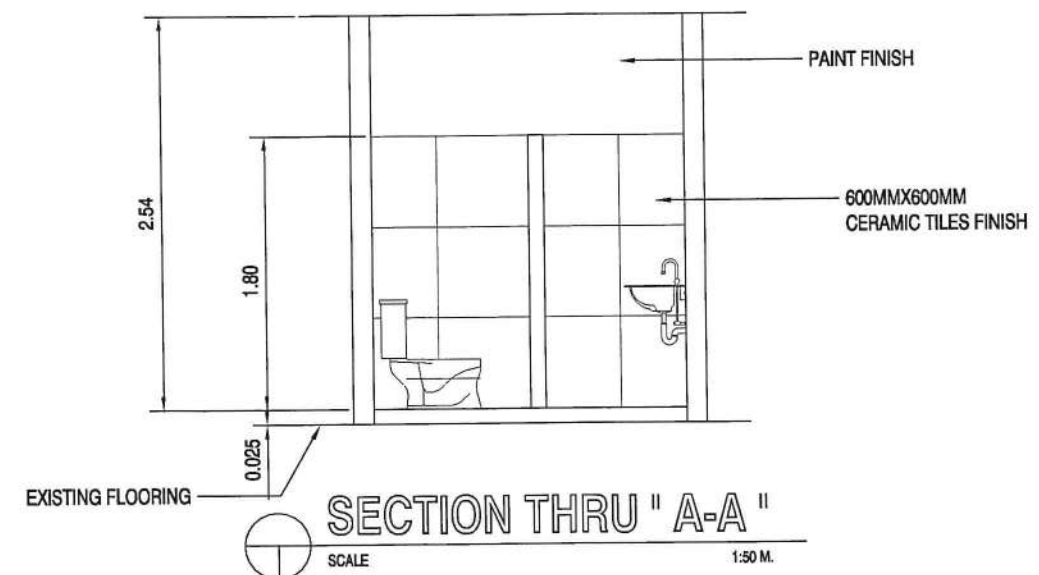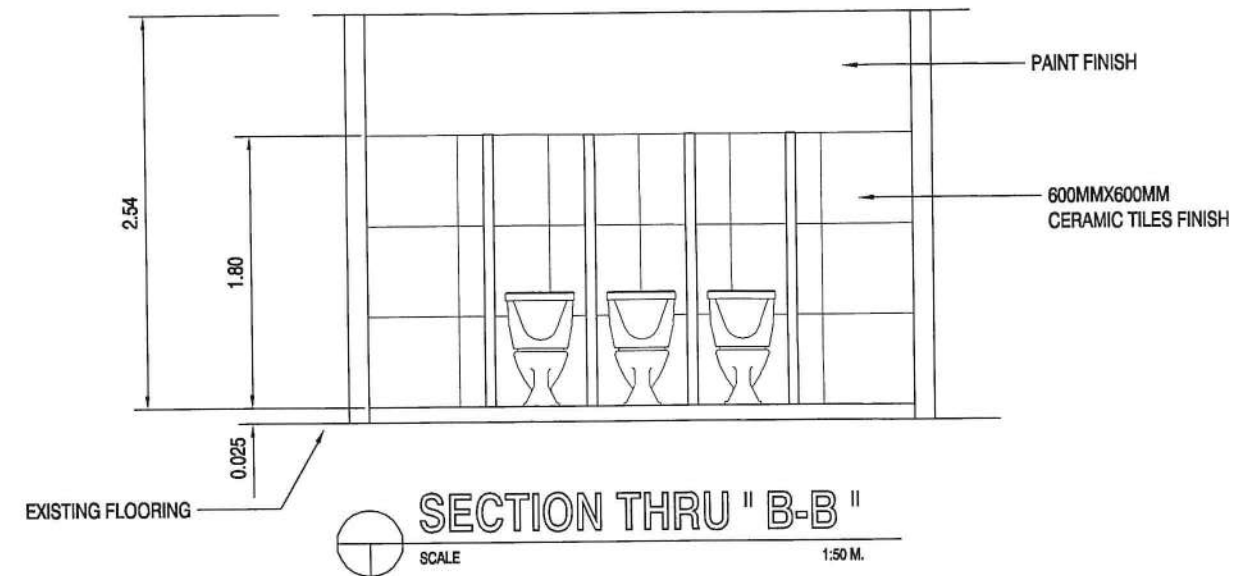

Office of Engineering
& Technical Services
Philippine General Hospital
University of the Philippines
Taft Avenue, Ermita, Manila



PROJECT TITLE:

**PROPOSED RENOVATION OF TOILETS
AND CONSTRUCTION OF SEPTIC TANK**

LOCATION: Ground Floor, Dormitory 3 Building,
UP-PGH Compound, Taft Avenue, Ermita, Manila

CADD BY: Rhyann Jay B. Galenzoga

043020

PREPARED BY:

ENGR. JMUEL Q. DEL MONTE
Engineer II, PMU

END - USER:

VILMA Q. VIESCA
Dormitory Manager III

ENDORSED BY:

ENGR. LORNA G. POUNTAIN
Head/Project Management Unit

RECOMMENDING APPROVAL:

MARIA TERESA JULIETTA U. BENEDICTO, MD
Deputy Director for Administration

APPROVED:

GERARDO D. LEGASPI, MD
Director, UP-PGH


SHEET NO.:

2

7

JUL 23 2020

ROBINSONS PLACE MANILA

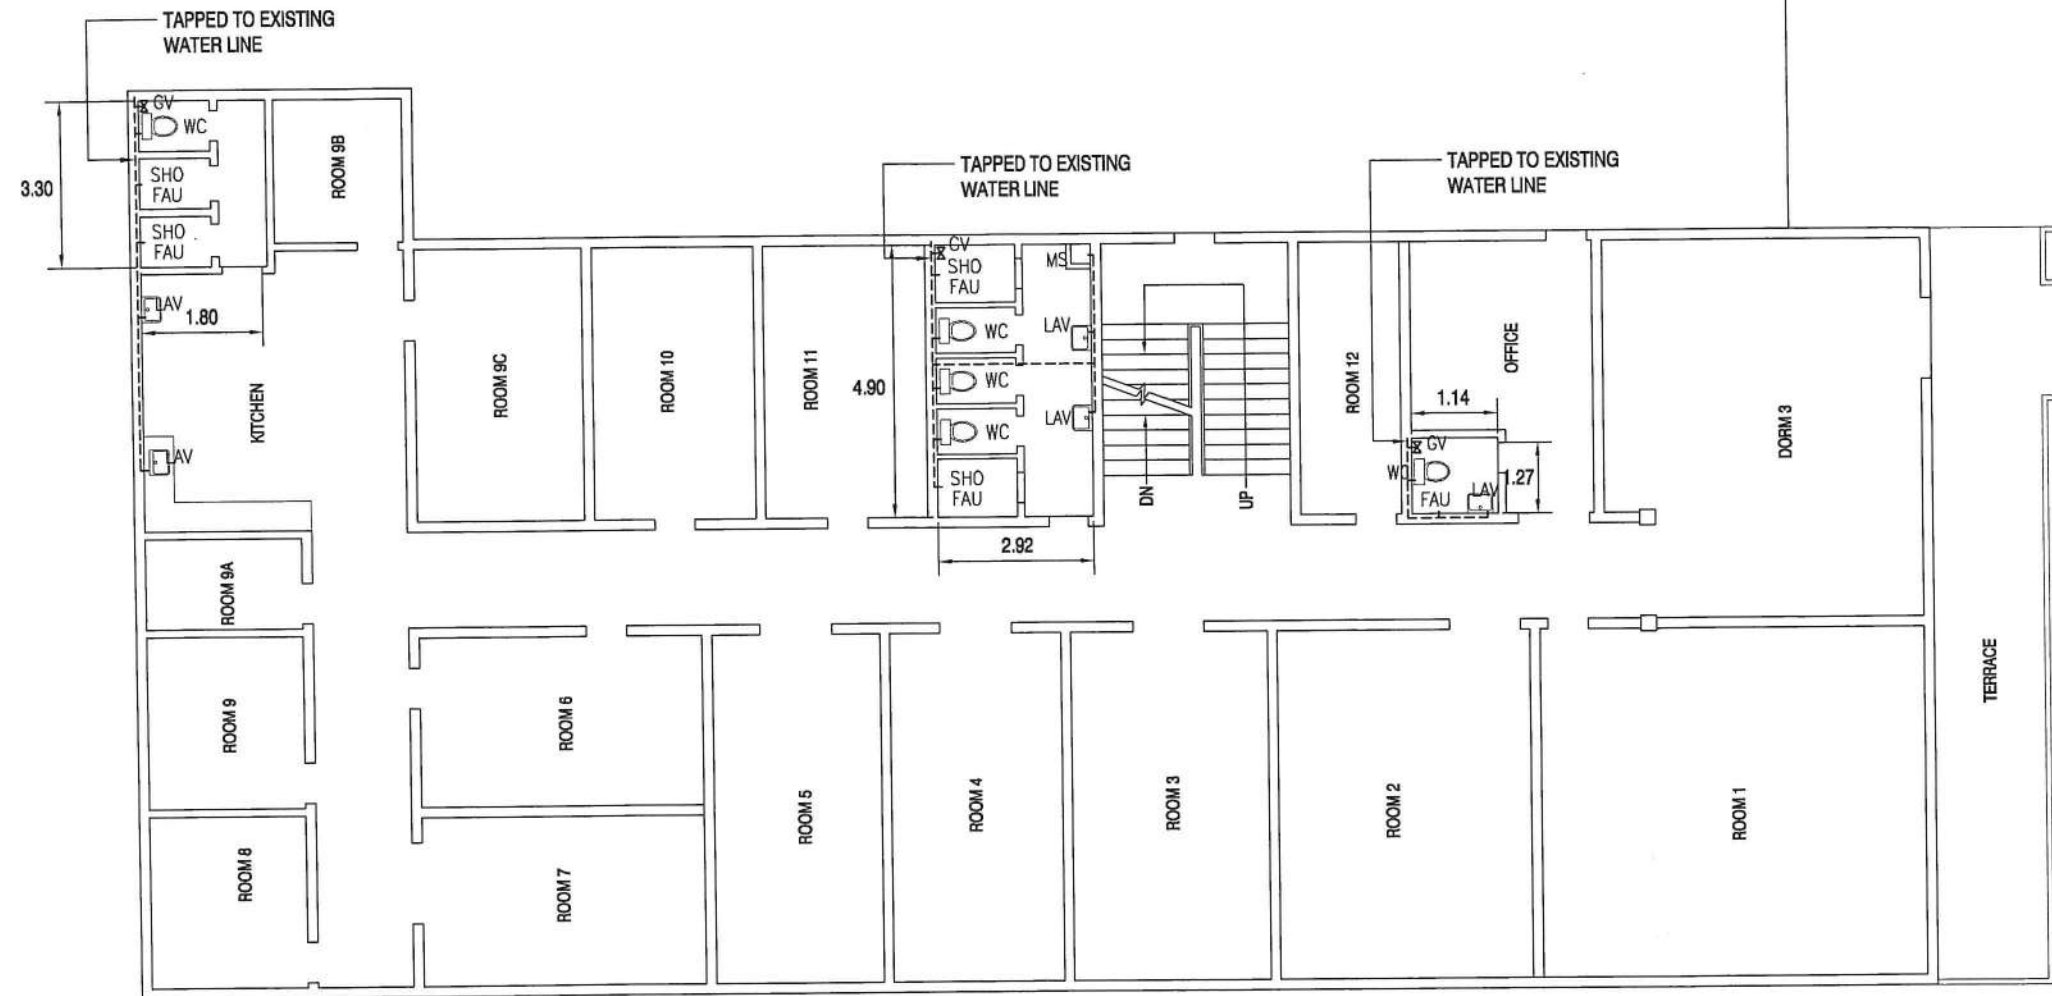

 **WATER LINE LAY-OUT**
SCALE 1:150M.



Office of Engineering
& Technical Services
Philippine General Hospital
University of the Philippines
Taft Avenue, Ermita, Manila



PROJECT TITLE:

**PROPOSED RENOVATION OF TOILETS
AND CONSTRUCTION OF SEPTIC TANK**

LOCATION: Ground Floor, Dormitory 3 Building,
UP-PGH Compound, Taft Avenue, Ermita, Manila

CADD BY: Rhyen Jay B. Galenzoga

043020

PREPARED BY:


ENGR. DANILO H. METRILLO
Head, Plumbing unit

END - USER:


VILMA Q. VIESCA
Dormitory Manager III

ENDORSED BY:


ENGR. LORNA G. POUNTAIN
Head, Project Management Unit


RECOMMENDING APPROVAL:


MARIA TERESA JULIETA U. BENEDICTO, MD
Deputy Director for Administration


APPROVED:



GERARDO D. LEGASPI, MD
Director, UP-PGH

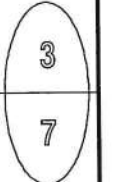SHEET NO.:

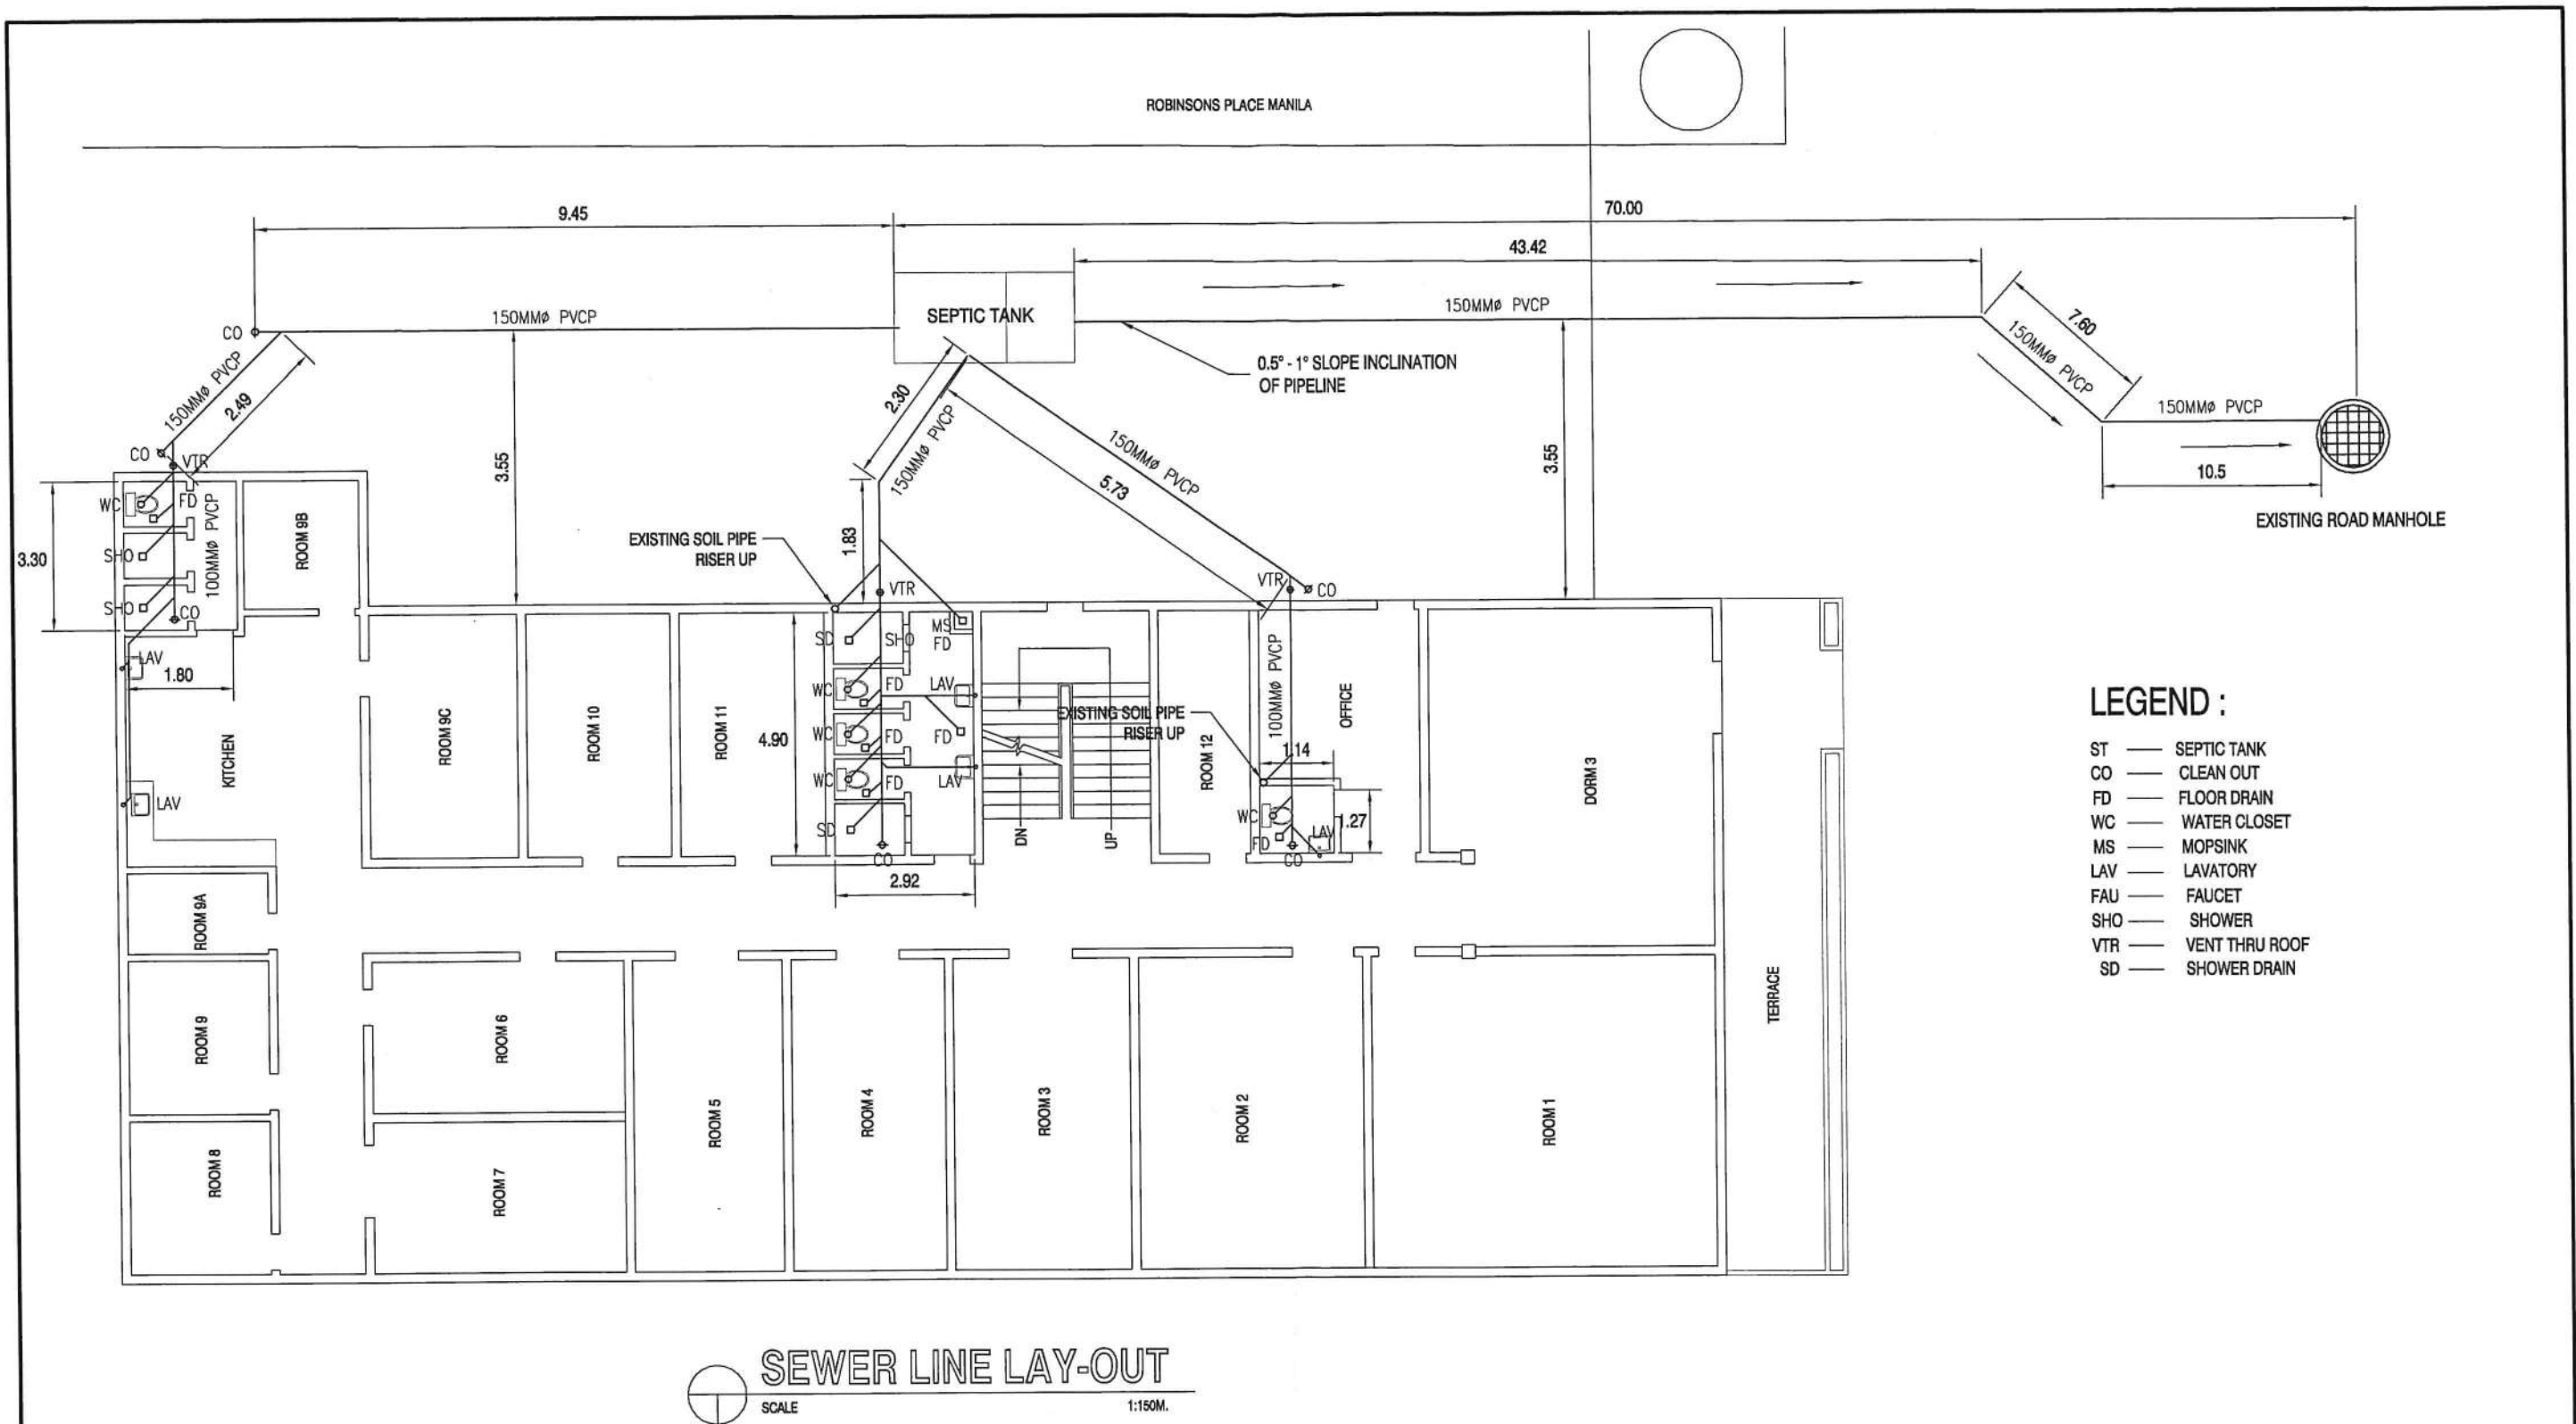

JUL 23 2020



 <p>Office of Engineering & Technical Services Philippine General Hospital University of the Philippines Taft Avenue, Ermita, Manila</p>	PROJECT TITLE:		PREPARED BY:	END - USER:	ENDORSED BY:	RECOMMENDING APPROVAL:	APPROVED:	SHEET NO.:
	PROPOSED RENOVATION OF TOILETS AND CONSTRUCTION OF SEPTIC TANK							4
	LOCATION: Ground Floor, Dormitory 3 Building, UP-PGH Compound, Taft Avenue, Ermita, Manila		ENGR. DANILO H. METRILLO Head, Plumbing unit	VILMA Q. VIESCA Dormitory Manager III	ENGR. LORNA G. POUNTAIN Head, Project Management Unit	MARIA TERESA JULIETA U. BENEDICTO, MD Deputy Director for Administration	GERARDO D. LEGASPI, MD Director, UP-PGH	7
CADD BY: Rhyan Jay B. Galenzoga		043020						


JUL 23 2020

LEGEND :

ST — SEPTIC TANK
CO — CLEAN OUT
FD — FLOOR DRAIN
WC — WATER CLOSET
MS — MOPSINK
LAV — LAVATORY
FAU — FAUCET
SHO — SHOWER
GV — GATE VALVE
SD — SHOWER DRAIN

GENERAL NOTES :


1. ALL PLUMBING WORKS INCLUDED HEREIN SHALL BE EXECUTED ACCORDING TO THE PROVISIONS OF THE PHILIPPINE CODE, AND REGULATION OF THE CITY.
2. ALL WORKS SHALL BE EXECUTED IN CLOSE COORDINATION WITH OTHER TRADES THE ARCHITECT/ ENGINEER SHALL BE NOTIFIED IMMEDIATELY OF ANY CONFLICT OR DISCREPANCY FOUND THEREIN.
3. THE CONTRACTOR SHALL BE FULLY RESPONSIBLE FOR THE EXACT LOCATION AND DIMENSIONS OF ALL REQUIRED WALL AND FLOOR OPENINGS.
4. PIPE SHALL BE INSTALLED AS INDICATED, ANY RELOCATION REQUIRED FOR PROPER EXECUTION OF OTHER TRADES SHALL BE WITH PRIOR APPROVAL OF THE ARCHITECT/ENGINEER.
5. PROPOSED SANITARY UTILITIES SHALL CONFORM TO THE ACTUAL LOCATION, DEPTH AND INVERT ELEVATION OF ALL EXISTING PIPE AND STRUCTURES AS VERIFIED BY THE CONTRACTOR.
6. ALL SLOPES FOR HORIZONTAL BRANCHES OF STORM AND SANITARY DRAINAGE SHALL MAINTAIN 2 % SLOPE AS MINIMUM AND ALL DRAIN WASTE LINE SHALL BE RUN AT A MINIMUM SLOPE OF 1
7. PROVIDE AIR CHAMBER TO ALL INDIVIDUAL BRANCHES TO FIXTURES AND OR EQUIPMENT 300mm LONG FOR A 13mm DIAMETER VERTICAL AND 400mm LONG FOR A 19mm DIAMETER VERTICAL.
8. SIZE OF WATER SUPPLY PIPES AND DRAINS OF FIXTURES SHALL BE IN ACCORDANCE WITH THE MANUFACTURERS INSTRUCTIONS.
9. UNLESS OTHERWISE INDICATED, ALL FIXTURES SHALL BE VERTED.

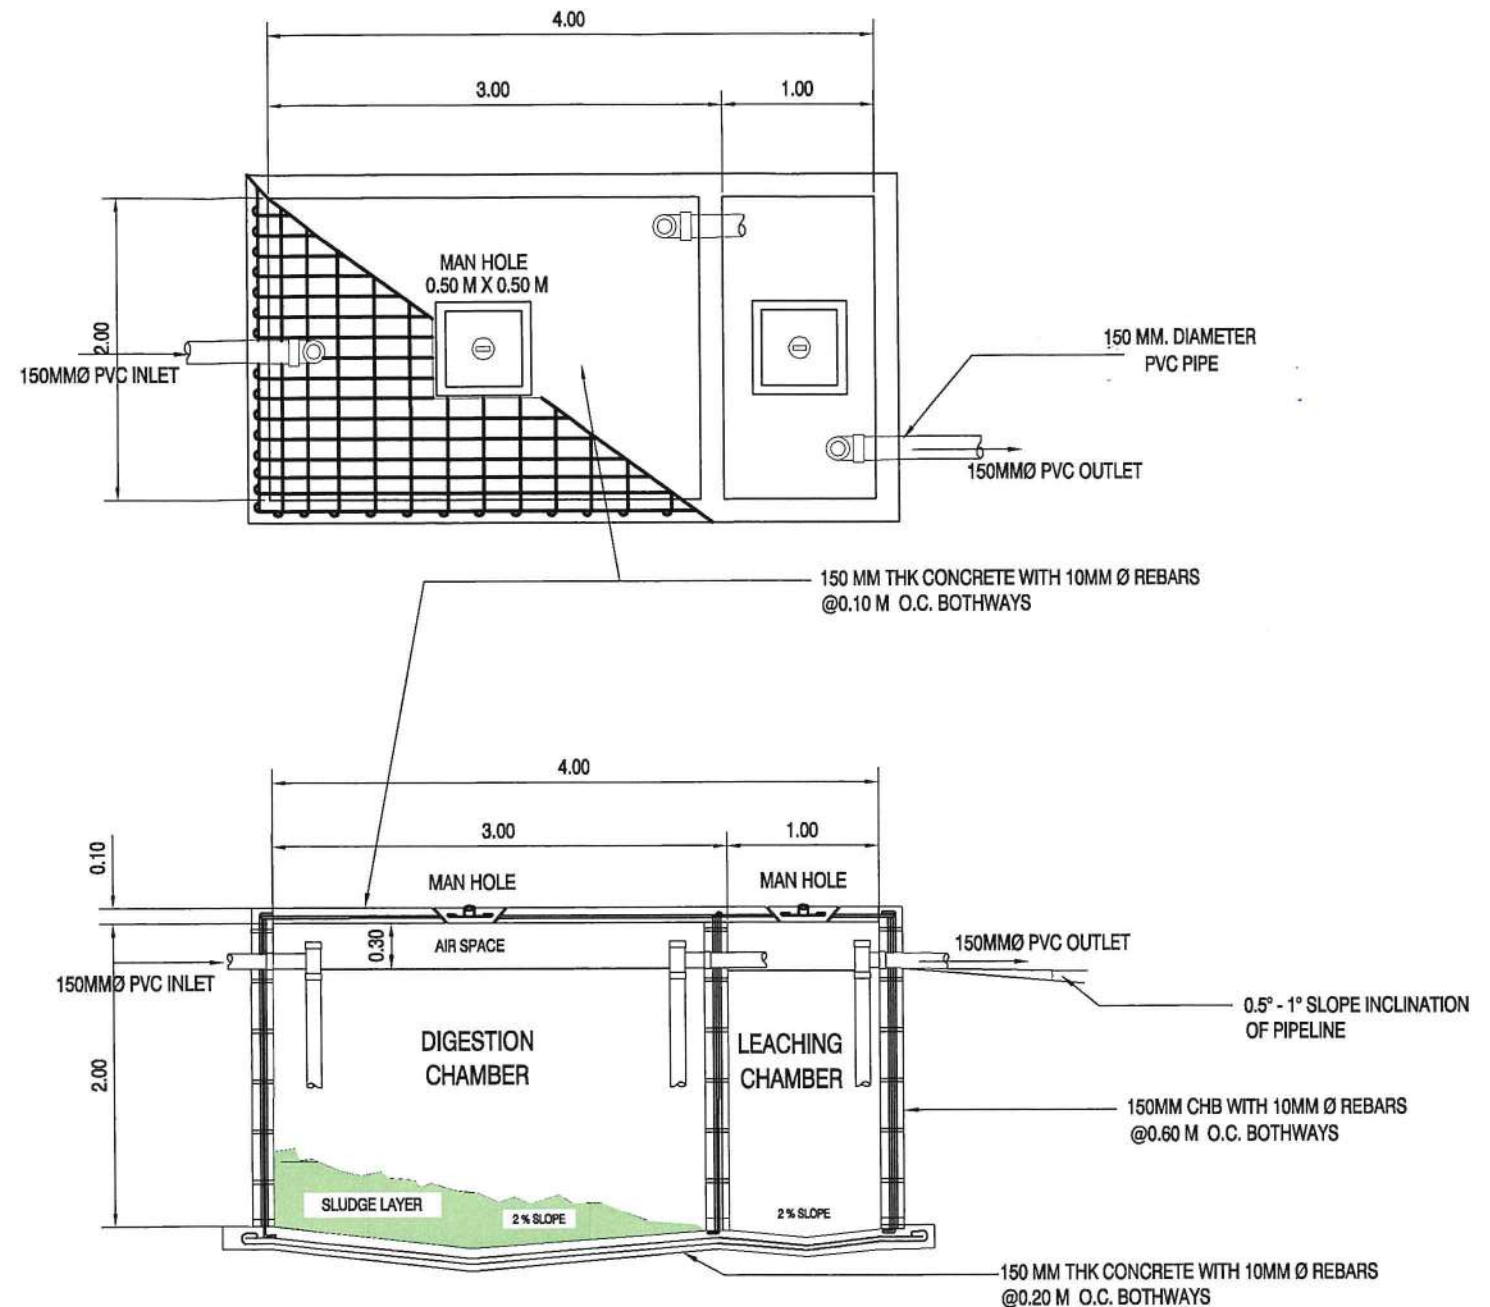

DETAIL OF SEPTIC TANK
SCALE 1:50 M.

	Office of Engineering & Technical Services Philippine General Hospital University of the Philippines Taft Avenue, Ermita, Manila		PROJECT TITLE: PROPOSED RENOVATION OF TOILETS AND CONSTRUCTION OF SEPTIC TANK LOCATION: Ground Floor, Dormitory 3 Building, UP-PGH Compound, Taft Avenue, Ermita, Manila CADD BY: Rhyen Jay B. Galenzoga 043020	PREPARED BY: ENGR. JIMUEL Q. DEL MONTE Engineer II, PMU	END - USER: VILMA Q. VIESCA Dormitory Manager III	ENDORSED BY: ENGR. LORNA G. POUNTAIN Head/Project Management Unit	RECOMMENDING APPROVAL: MARIA TERESA JULIETA U. BENEDICTO, MD Deputy Director for Administration	APPROVED: GERARDO D. LEGASPI, MD Director, UP-PGH	SHEET NO.: <div>5 7</div>
--	--	--	--	---	---	---	---	---	----------------------------------

ROBINSONS PLACE MANILA

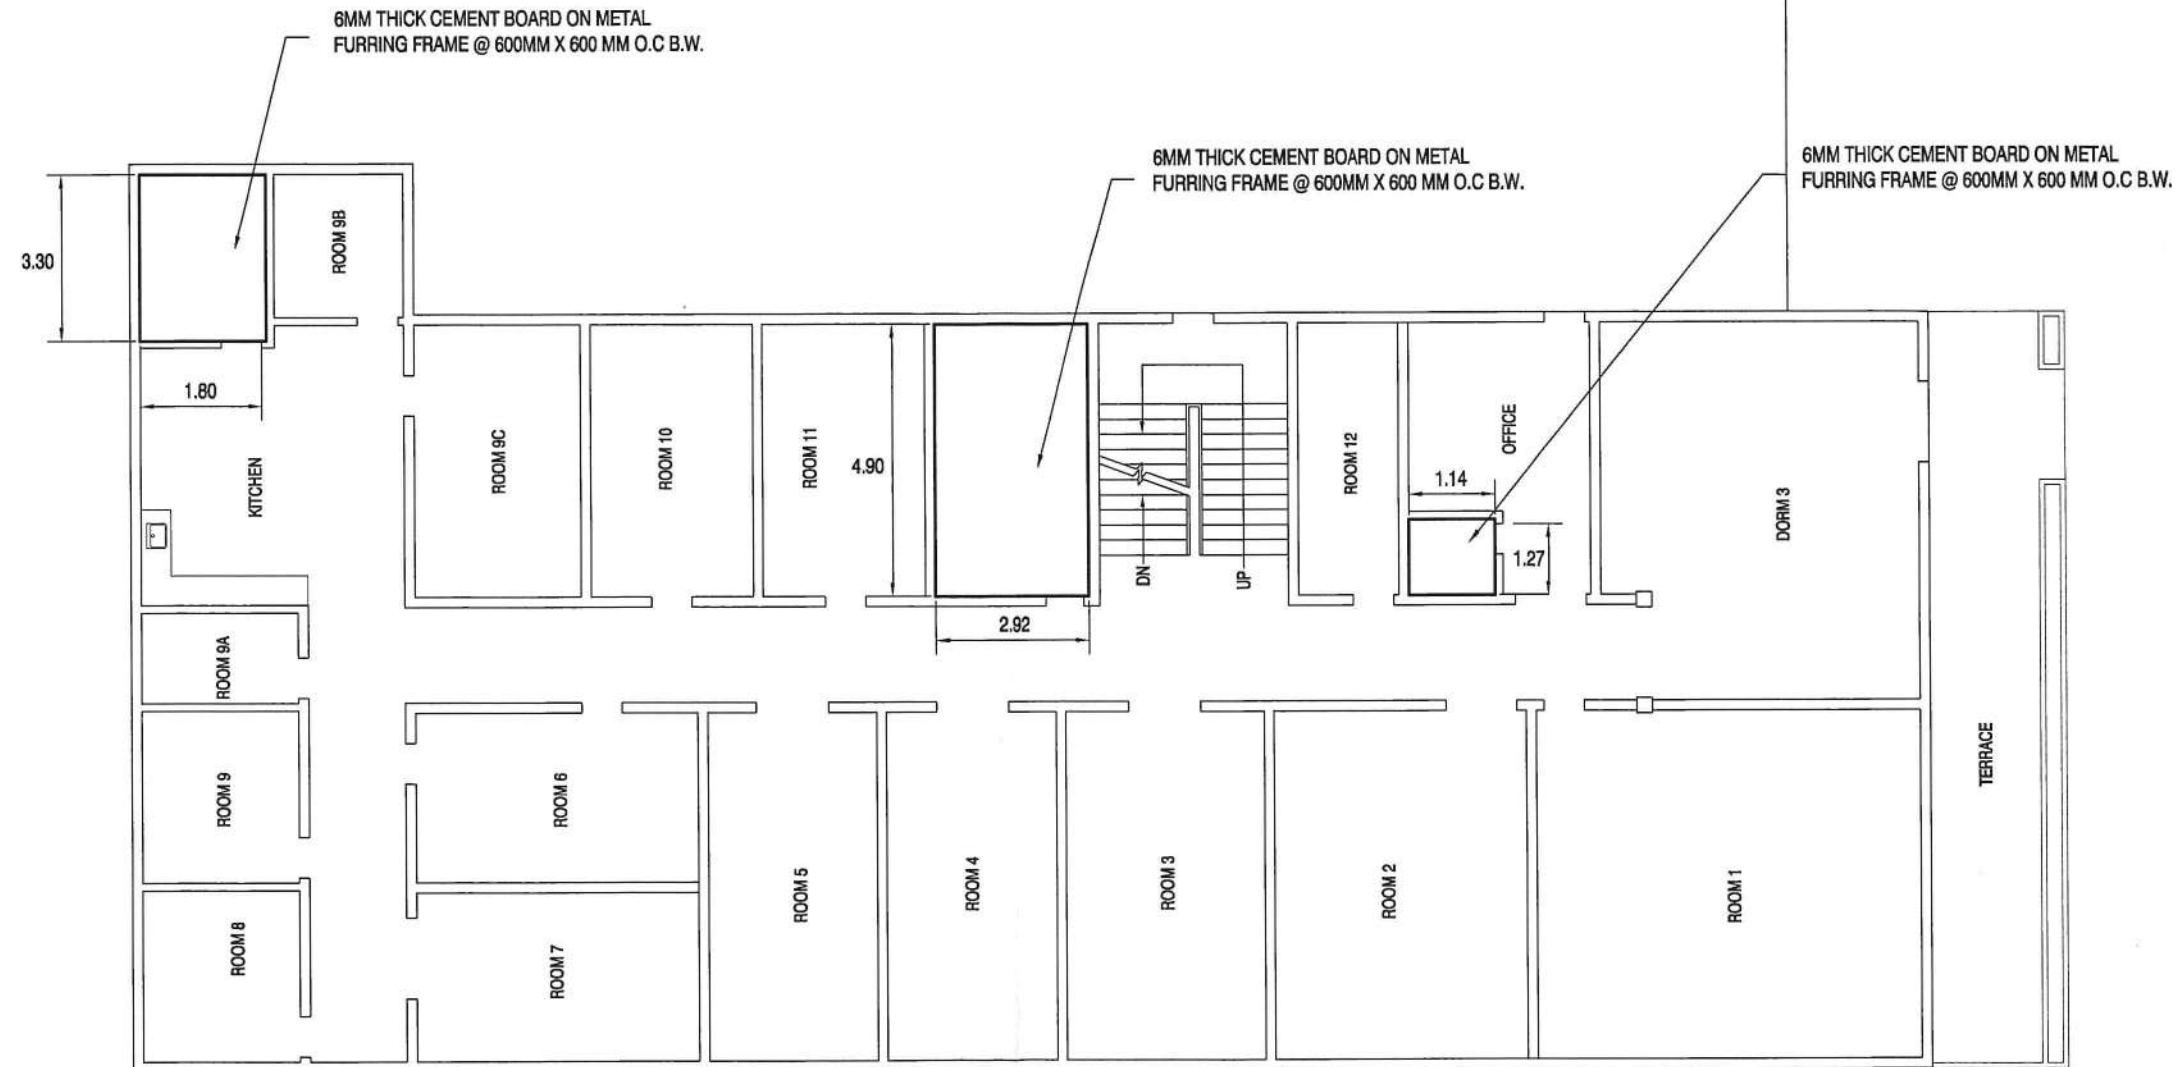






 REFLECTIVE CEILING PLAN
SCALE 1:150M.



Office of Engineering
& Technical Services
Philippine General Hospital
University of the Philippines
Taft Avenue, Ermita, Manila



PROJECT TITLE:	PREPARED BY:	END - USER:	ENDORSED BY:	RECOMMENDING APPROVAL:	APPROVED:	SHEET NO.:
PROPOSED RENOVATION OF TOILETS AND CONSTRUCTION OF SEPTIC TANK LOCATION: Ground Floor, Dormitory 3 Building, UP-PGH Compound, Taft Avenue, Ermita, Manila CADD BY: Rhyann Jay B. Galenzoga 043020	 ENGR. JIMUEL Q. DEL MONTE Engineer II, PMU	 VILMA Q. VIESCA Dormitory Manager III	 ENGR. LORNA G. POUNTAIN Head, Project Management Unit	 MARIA TERESA JULIETA U. BENEDICTO, MD Deputy Director for Administration	 GERARDO D. LEGASPI, MD Director, UP-PGH	<div>7</div> <div>7</div>

JUL 23 2020