

LIGHTING FIXTURES LEGENDS	
	150MM Ø 1X18W LED RECESSED DOWNLIGHT
	300MM X 1200 MM SUSPENDED / SURFACE-MOUNTED INDUSTRIAL TYPE, POWDER-COATED REFLECTOR 2X19W OSRAM LED LAMP
	COVE LIGHTING IN 1x10W LED LAMP
	600X600MM RECESSED TROFFER LUMINAIRE WITH STANDARD LOUVER MATT REFLECTOR 4X9W OSRAM LED LAMP
	600X600MM RECESSED TROFFER LUMINAIRE WITH STANDARD LOUVER MATT REFLECTOR 4X9W OSRAM LED LAMP WITH DIMMER
	300X1200MM RECESSED LUMINAIRE CLEAN ROOM FIXTURE W/ 2 X 32W T8 PANASONIC HF FLUORESCENT LAMP
	BRACKET LIGHTING FIXTURE W/ 1X 4W LED LAMP
	WALL MOUNTED LIGHTING FIXTURE
EP	EXPLOSION PROOF
CEILING FINISHES LEGENDS	
C-1	600X600MM REGULAR BEVELLED ACOUSTIC TILES ON POWDER COATED ALUMINUM RUNNERS
C-2	10MM THK UNISPAN MOISTURE RESISTANT GYPSUM BOARD ON METAL FURRINGS AND RUNNERS, FLAT LATEX PAINT FINISH
C-3	10MM THK UNISPAN MOISTURE RESISTANT GYPSUM BOARD ON METAL FURRINGS AND RUNNERS, ANTI-BACTERIAL LEVEL 1
C-4	10MM THK UNISPAN MOISTURE RESISTANT GYPSUM BOARD ON METAL FURRINGS AND RUNNERS, ANTI-BACTERIAL LEVEL 2
C-5	10MM THK UNISPAN MOISTURE RESISTANT GYPSUM BOARD ON METAL FURRINGS AND RUNNERS, ANTI-BACTERIAL LEVEL 3
C-6	1220 MM x 2440 MM BORAL ECHO STOP
C-7	6MM THK. FROSTED ACRYLIC SHEET W/ S.S. CUT-OUT DESIGN ON STAINLESS STEEL T-RUNNERS, G.I. HANGERS AND CLIPS
C-8	HPL "WOOD SERIES" VENEER W/ 6MM THK MDF BACKING
C-9	200MM WIDE POWDER COATED G.I. CEILING PLANKS
C-10	PAINTED EXPOSED UNDERSIDE OF SLAB, ACRYLIC LATEX FINISH
CORNICE LEGEND	
COR-1	GLASS PLASTER CORNICE
MEPF LEGENDS	
	EXISTING SPRINKLER
	EXISTING AC GRILLE
	EXISTING CEILING FAN

PHILIPPINE GENERAL HOSPITAL

INFRASTRUCTURE PROJECT

P05 ELEVATOR LOBBY

MANILA, PHILIPPINES

PROJECT

OFFICIAL REPRESENTATIVE

ARCHITECTURAL & INTERIOR DESIGN CONSULTANT

G/F PICO BUILDING

2242 DON CHINO ROCES AVENUE

MAKATI CITY, PHILIPPINES

Tel : (00 63 2) 817-1115, (632) 817-1116

Fax : (00 63 2) 817-0792

Email : archion@eastern.com.ph

ARCHITECT:

Daniel A. Lichauco

PTR NO. : 7335918

PRC NO. : 9243

DATE ISSUED : JANUARY 07, 2019

DATE ISSUED : JUNE 17, 1987

PLACE ISSUED : MAKATI CITY

VALID UNTIL : DECEMBER 17, 2021

TIN NO. : 172958490

UAP-IAPOA : 07523 163463 070516

QUANTITY SURVEYOR:

UNI SYSTEM

UNI SYSTEM CONSULTANCY

INTERNATIONAL INCORPORATED

Tel : (632) 586 5928

Email : unisystem.consult.us@gmail.com

STRUCTURAL ENGINEERING CONSULTANT:

ANTONIO V. GUTIERREZ & ASSOCIATES

Tel : (00 63 2) 725 6265

Fax : (00 63 2) 724 1687

Email : antonio.v.gutierrez@yahoo.com

MEPF CONSULTANT:

Meinhardt Philippines, Inc.

25th Floor Chatham House 116 Valero cor.

V.A. Rufino St. Salcedo Village, Makati City

Tels. (632) 887-1391 E-mail mpi@meinhardt.com.ph

Fax (632) 887-1172

ENGINEERING CONSULTANT:

PTR NO. :

PRC NO. :

TIN NO. :

DATE ISSUED :

PLACE ISSUED :

VALID UNTIL :

DATE:

NO.

REVISIONS:

GRAPHIC SCALE :

0 10 20 30 40

GRAPHIC SCALE 1:100 MTS.

DRAWING CONTENTS :

ELEVATOR LOBBY - TYPICAL

FOURTH TO SIXTH FLOOR

REFLECTED CEILING PLAN

PROJECT NO. :

SCALE : 1:100 MTS

DRAWN BY : J.D.V.

DATE DRAWN : 2016/12/14


CHECKED BY :

FILE NAME :

SHEET NO.

P05-A-404



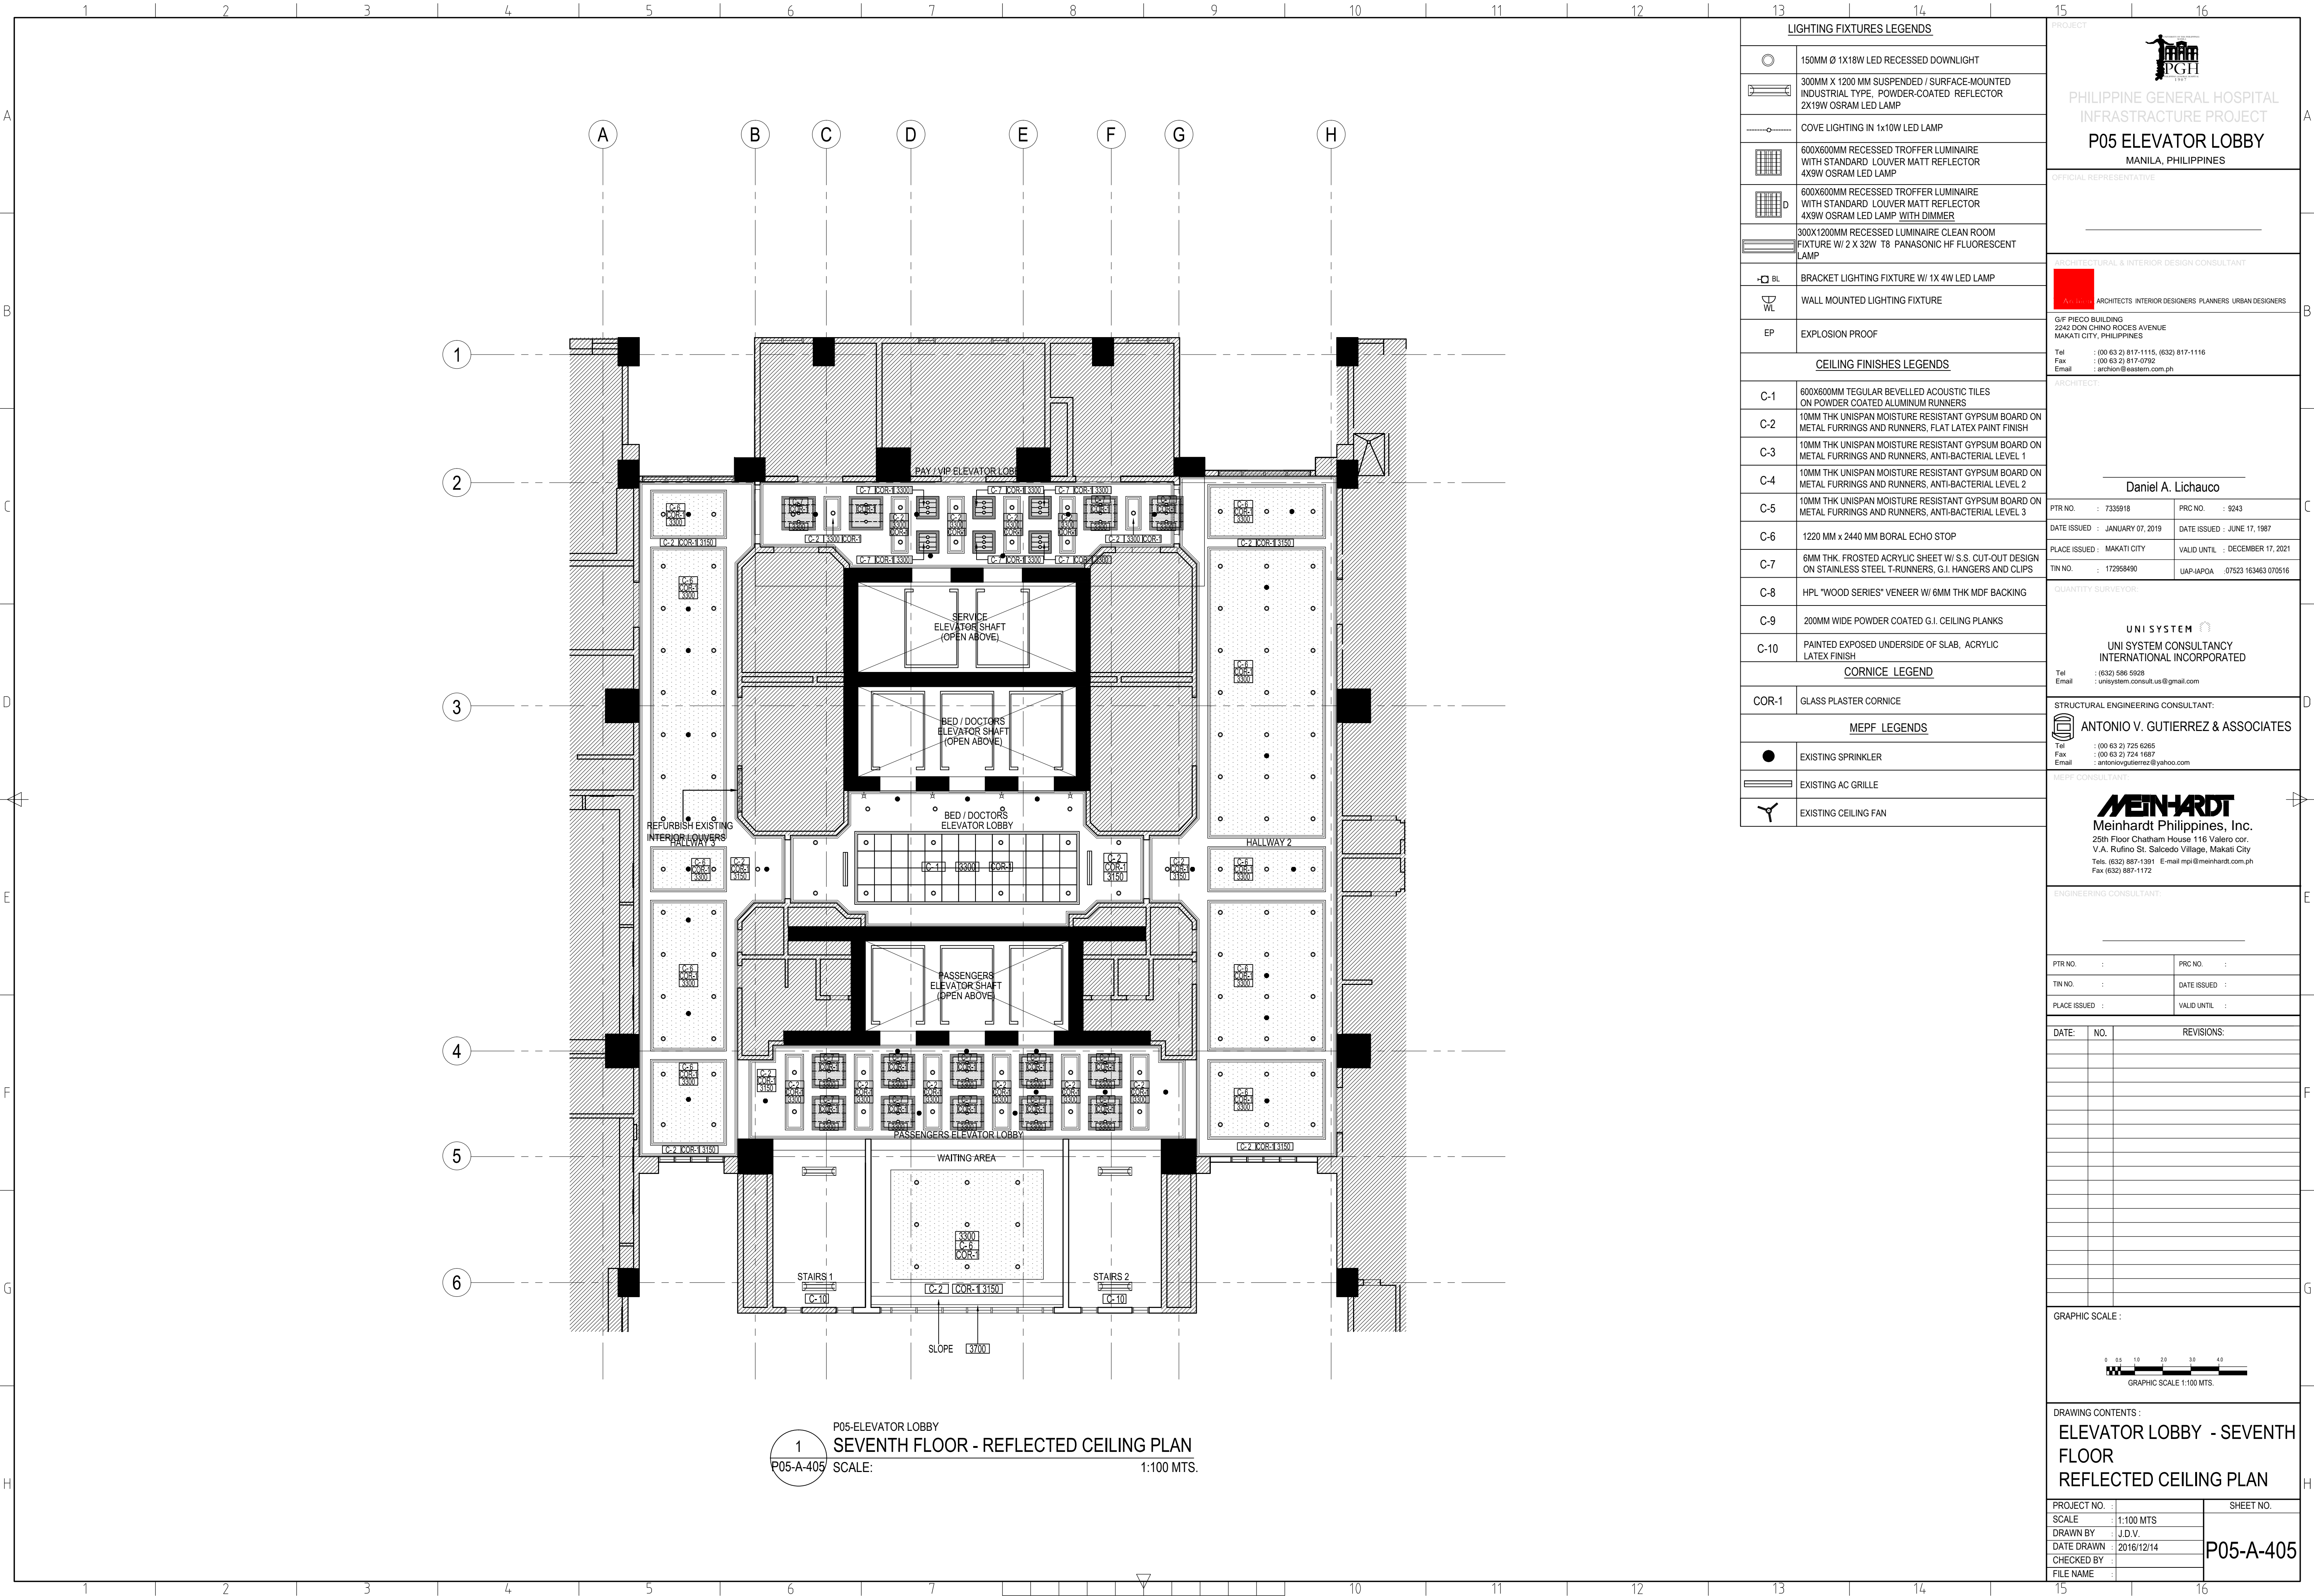

LIGHTING FIXTURES LEGENDS	
	150MM Ø 1X18W LED RECESSED DOWNLIGHT
	300MM X 1200 MM SUSPENDED / SURFACE-MOUNTED INDUSTRIAL TYPE, POWDER-COATED REFLECTOR 2X19W OSRAM LED LAMP
	COVE LIGHTING IN 1x10W LED LAMP
	600X600MM RECESSED TROFFER LUMINAIRE WITH STANDARD LOUVER MATT REFLECTOR 4X9W OSRAM LED LAMP
	600X600MM RECESSED TROFFER LUMINAIRE WITH STANDARD LOUVER MATT REFLECTOR 4X9W OSRAM LED LAMP WITH DIMMER
	300X1200MM RECESSED LUMINAIRE CLEAN ROOM FIXTURE W/ 2 X 32W T8 PANASONIC HF FLUORESCENT LAMP
	BRACKET LIGHTING FIXTURE W/ 1X 4W LED LAMP
	WALL MOUNTED LIGHTING FIXTURE
	EXPLOSION PROOF
CEILING FINISHES LEGENDS	
C-1	600X600MM REGULAR BEVELLED ACOUSTIC TILES ON POWDER COATED ALUMINUM RUNNERS
C-2	10MM THK UNISPAN MOISTURE RESISTANT GYPSUM BOARD ON METAL FURRINGS AND RUNNERS, FLAT LATEX PAINT FINISH
C-3	10MM THK UNISPAN MOISTURE RESISTANT GYPSUM BOARD ON METAL FURRINGS AND RUNNERS, ANTI-BACTERIAL LEVEL 1
C-4	10MM THK UNISPAN MOISTURE RESISTANT GYPSUM BOARD ON METAL FURRINGS AND RUNNERS, ANTI-BACTERIAL LEVEL 2
C-5	10MM THK UNISPAN MOISTURE RESISTANT GYPSUM BOARD ON METAL FURRINGS AND RUNNERS, ANTI-BACTERIAL LEVEL 3
C-6	1220 MM x 2440 MM BORAL ECHO STOP
C-7	6MM THK. FROSTED ACRYLIC SHEET W/ S.S. CUT-OUT DESIGN ON STAINLESS STEEL T-RUNNERS, G.I. HANGERS AND CLIPS
C-8	HPL "WOOD SERIES" VENEER W/ 6MM THK MDF BACKING
C-9	200MM WIDE POWDER COATED G.I. CEILING PLANKS
C-10	PAINTED EXPOSED UNDERSIDE OF SLAB, ACRYLIC LATEX FINISH
CORNICE LEGEND	
COR-1	GLASS PLASTER CORNICE
MEPF LEGENDS	
	EXISTING SPRINKLER
	EXISTING AC GRILLE
	EXISTING CEILING FAN



PHILIPPINE GENERAL HOSPITAL  
INFRASTRUCTURE PROJECT  
**P05 ELEVATOR LOBBY**  
MANILA, PHILIPPINES

OFFICIAL REPRESENTATIVE

ARCHITECTURAL & INTERIOR DESIGN CONSULTANT

 ARCHITECTS INTERIOR DESIGNERS PLANNERS URBAN DESIGNERS

G/F PIECO BUILDING  
2242 DON CHINO ROCES AVENUE  
MAKATI CITY, PHILIPPINES

Tel : (00 63 2) 817-1115, (632) 817-1116  
Fax : (00 63 2) 817-0792  
Email : archon@eastern.com.ph

ARCHITECT

**Daniel A. Lichauco**

PTR NO. : 7335918 PRC NO. : 9243

DATE ISSUED : JANUARY 07, 2019 DATE ISSUED : JUNE 17, 1987

PLACE ISSUED : MAKATI CITY VALID UNTIL : DECEMBER 17, 2021

TIN NO. : 172958490 UAP-IAPDA 07523 163463 070516

QUANTITY SURVEYOR

**UNI SYSTEM**

UNI SYSTEM CONSULTANCY  
INTERNATIONAL INCORPORATED

Tel : (632) 586 5928  
Email : unisystem.consult.us@gmail.com

STRUCTURAL ENGINEERING CONSULTANT:

 **ANTONIO V. GUTIERREZ & ASSOCIATES**

Tel : (00 63 2) 725 6265  
Fax : (00 63 2) 724 1687  
Email : antoniogutierrez@yahoo.com

MEPF CONSULTANT:

**MEINHARDT**

Meinhardt Philippines, Inc.  
25th Floor Chatham House 116 Valero cor.  
V.A. Rufino St. Salcedo Village, Makati City  
Tels. (632) 887-1391 E-mail mpi@meinhardt.com.ph  
Fax (632) 887-1172

ENGINEERING CONSULTANT:

PTR NO. : PRC NO. :  
TIN NO. : DATE ISSUED :  
PLACE ISSUED : VALID UNTIL :  
DATE: NO. REVISIONS:

GRAPHIC SCALE :

0 10 20 30 40  
GRAPHIC SCALE 1:100 MTS.


DRAWING CONTENTS :






**ELEVATOR LOBBY - SEVENTH FLOOR  
REFLECTED CEILING PLAN**


 
 
 
 
 
 


 
 
 
PROJECT NO. :	1:100 MTS	SHEET NO. <b>P05-A-405</b>
SCALE :	J.D.V.	
DRAWN BY :	2016/12/14	
DATE DRAWN :		
CHECKED BY :		
FILE NAME :		

 


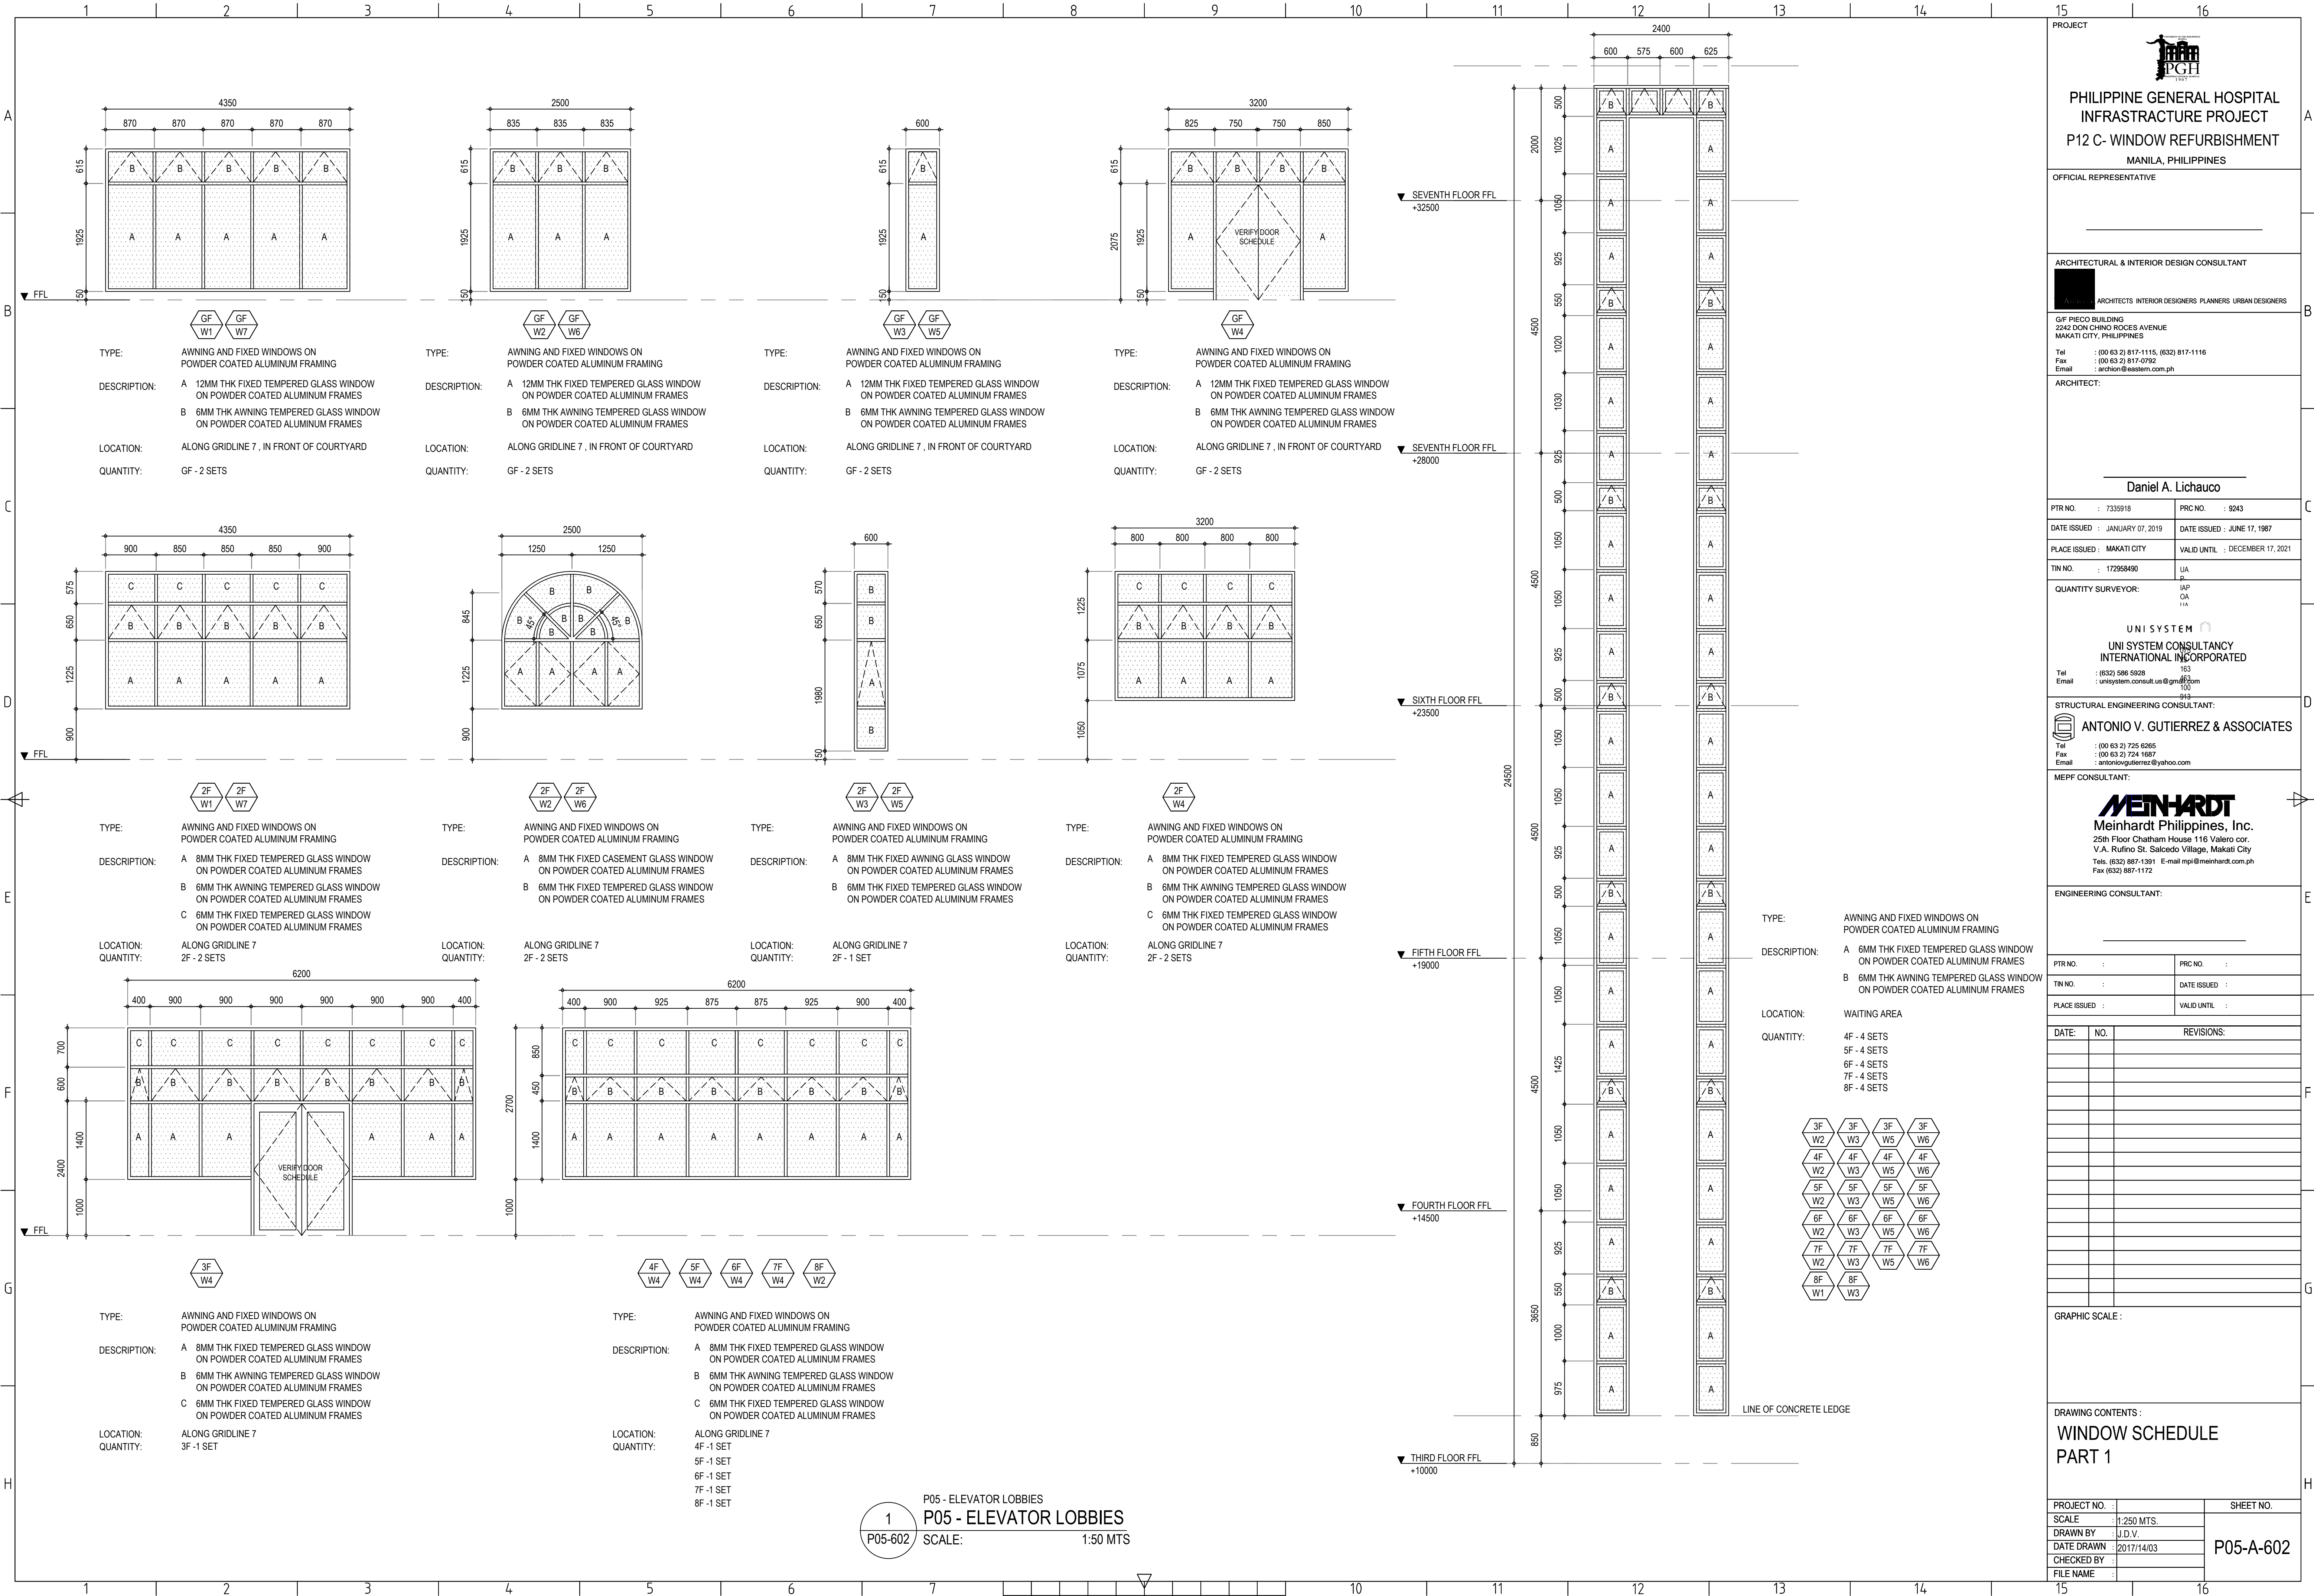

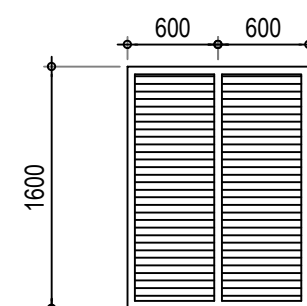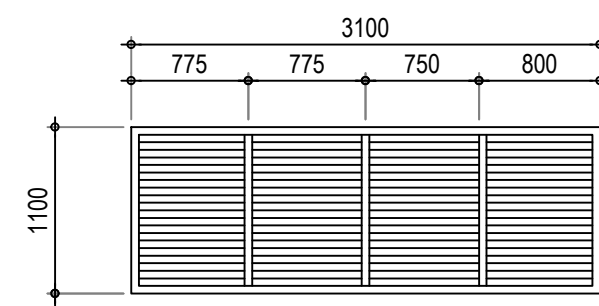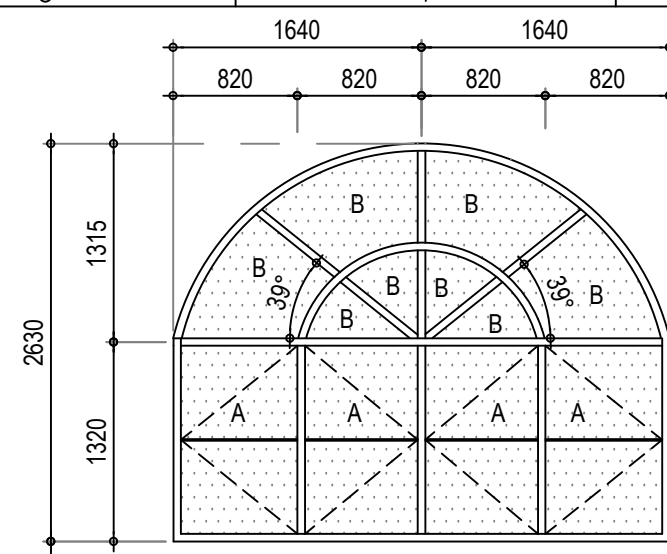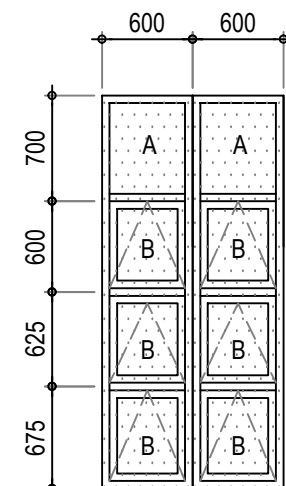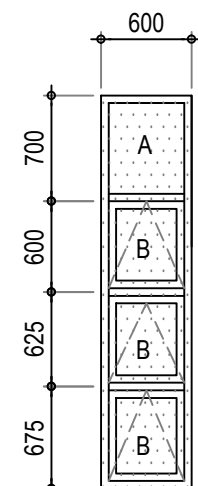


 
 
 
 
 
 
 
 




 
 






						
						
TYPE:	AWNING AND FIXED WINDOWS ON POWDER COATED ALUMINUM FRAMING					
DESCRIPTION:	<p>A 6MM THK FIXED TEMPERED GLASS WINDOW ON POWDER COATED ALUMINUM FRAMES</p> <p>B 6MM THK AWNING TEMPERED GLASS WINDOW ON POWDER COATED ALUMINUM FRAMES</p>					
LOCATION:	ALONG GRIDLINE 1, IN FRONT OF COURTYARD					
QUANTITY:	GF - 2 SETS					

	
TYPE:	AWNING AND FIXED WINDOWS ON POWDER COATED ALUMINUM FRAMING
DESCRIPTION:	A 6MM THK FIXED TEMPERED GLASS WINDOW ON POWDER COATED ALUMINUM FRAMES  B 6MM THK AWNING TEMPERED GLASS WINDOW ON POWDER COATED ALUMINUM FRAMES
LOCATION:	ALONG GRIDLINE 1, IN FRONT OF COURTYARD
QUANTITY:	GF - 2 SETS

	4F W1	4F W8	4F W9	4F W12	5F W1	5F W7	5F W8	5F W13
	6F W1	6F W8	6F W9	6F W12	7F W1	7F W7	7F W8	7F W11
TYPE:	AWNING AND FIXED WINDOWS ON POWDER COATED ALUMINUM FRAMING							
DESCRIPTION:	A 6MM THK FIXED TEMPERED GLASS WINDOW ON POWDER COATED ALUMINUM FRAMES							
	B 6MM THK AWNING TEMPERED GLASS WINDOW ON POWDER COATED ALUMINUM FRAMES							
LOCATION:	ALONG GRIDLINE 6, IN FRONT OF COURTYARD							
QUANTITY:	4F - 4 SETS				6F - 4 SETS			
	5F - 4 SETS				7F - 4 SETS			

TYPE:	STORM RESISTANT LOUVERS
REFURBISH OF:	1. PRIMED AND PAINTED METAL FRAMES AND LOUVERS
LOCATION:	4F FLOOR BETWEEN GRIDLINE B AND C 4F FLOOR BETWEEN GRIDLINE F AND G
QUANTITY:	4F - 2 SET

				
				
				
				
TYPE:	STORM RESISTANT LOUVERS			
REFURBISH OF:	PRIMED AND PAINTED METAL FRAMES AND LOUVERS			
LOCATION:	4F, 6F, 7F AND 8F FLOOR BETWEEN GRIDLINE B AND C  4F, 6F, 7F AND 8F FLOOR BETWEEN GRIDLINE B AND C			
QUANTITY:	4F - 2 SET 6F - 2 SET		7F - 2 SET 8F - 2 SET	

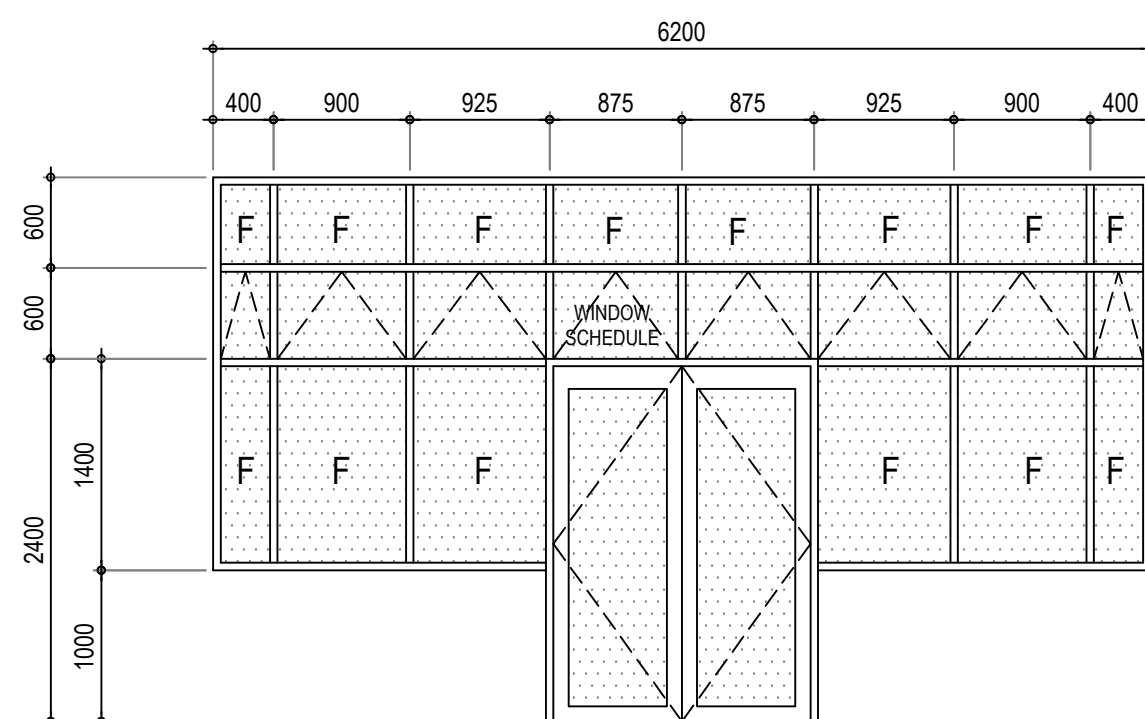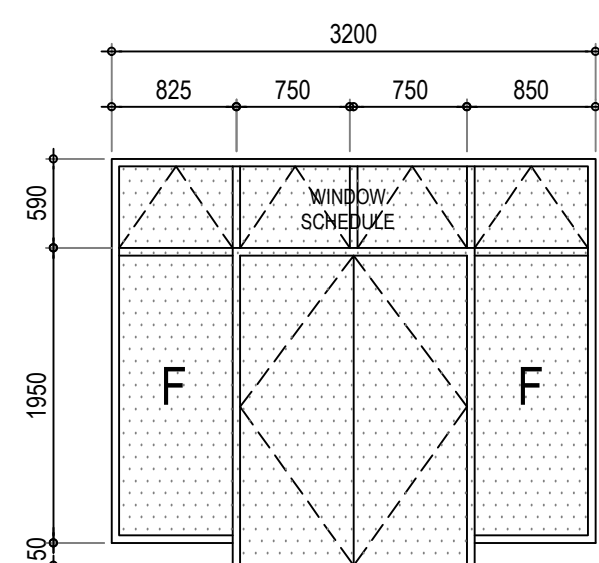



DESCRIPTION	10MM THK TEMPERED CLEAR GLASS ON ALUMINUM POWDER COATED FRAMES
DOOR FACE FIN	GLASS
VISION PANEL	NONE
LOUVER	NONE
JAMB	POWDER COATED ALUMINUM JAMB
HINGE	2 - HEAVY DUTY FLOOR HINGE FOR FRAMELESS GLASS DOORS
LOCKSET	VERIFY SUPPLIER
CLOSER	NONE
DOOR STOP	NONE
DOOR TRACK	NONE
FLUSHBOLT	NONE
PUSH PLATE	NONE
DOOR PULL	CUSTOM DESIGNED S.S. DOOR PULL
ARMOR PLATE/ KICK PLATE	NONE
THRESHOLD	NONE
DOOR SILENCER	NONE

DESCRIPTION	10MM THK TEMPERED CLEAR GLASS ON ALUMINUM POWDER COATED FRAMES
DOOR FACE FIN	GLASS
VISION PANEL	NONE
LOUVER	NONE
JAMB	POWDER COATED ALUMINUM JAMB
HINGE	2 - HEAVY DUTY FLOOR HINGE FOR FRAMELESS GLASS DOORS
LOCKSET	VERIFY SUPPLIER
CLOSER	NONE
DOOR STOP	NONE
DOOR TRACK	NONE
FLUSHBOLT	NONE
PUSH PLATE	NONE
DOOR PULL	CUSTOM DESIGNED S.S. DOOR PULL
ARMOR PLATE/ KICK PLATE	NONE
THRESHOLD	NONE
DOOR SILENCER	NONE

P05 - ELEVATOR LOBBIES  
**WINDOW SCHEDULE PART 2**  
 P05-A-603 SCALE: 1:50 MTS

P05 - ELEVATOR LOBBIES  
2 ALUMINIUM DOOR SCHEDULE  
P05-A-603 SCALE: 1:50 MTS

PROJECT	
	
<p align="center"><b>PHILIPPINE GENERAL HOSPITAL INFRASTRUCTURE PROJECT P12 C- WINDOW REFURBISHMENT</b></p> <p align="center"><b>MANILA, PHILIPPINES</b></p>	
OFFICIAL REPRESENTATIVE	
<hr/>	
ARCHITECTURAL & INTERIOR DESIGN CONSULTANT	
	ARCHITECTS INTERIOR DESIGNERS PLANNERS URBAN DESIGNERS
<p><b>GIF PECO BUILDING</b>  <b>2242 DON CHINO ROCES AVENUE</b>  <b>MAKATI CITY, PHILIPPINES</b></p>	
<p>Tel (00 63 2) 817-1115, (632) 817-1116          Fax (00 63 2) 817-0792          Email <a href="mailto:archin@eastern.com.ph">archin@eastern.com.ph</a></p>	
ARCHITECT:	
<hr/> <p align="center"><b>Daniel A. Lichauco</b></p>	

PTR NO. : 7335918	PRC NO. : 9243
DATE ISSUED : JANUARY 07, 2019	DATE ISSUED : JUNE 17, 1987
PLACE ISSUED : MAKATI CITY	VALID UNTIL : DECEMBER 17, 2021
TIN NO. : 172958490	UA P.
QUANTITY SURVEYOR:	IAP OA

**UNI SYSTEM** 

**UNI SYSTEM CONSULTANCY  
INTERNATIONAL INCORPORATED**

Tel : (632) 586 5928  
Email : [unisystem.consult.us@gmail.com](mailto:unisystem.consult.us@gmail.com)

STRUCTURAL ENGINEERING CONSULTANT:

 **ANTONIO V. GUTIERREZ & ASSOCIATES**

Tel : (00 63 2) 725 6265  
Fax : (00 63 2) 724 1687  
Email : antoniogutierrez@yahoo.com

MEPF CONSULTANT:

**MEINHARDT**  
Meinhardt Philippines, Inc.  
25th Floor Chatham House 116 Valero cor.  
V.A. Rufino St. Salcedo Village, Makati City  
Tels. (632) 887-1391 E-mail [mpgi@meinhardt.com.ph](mailto:mpgi@meinhardt.com.ph)  
Fax (632) 887-1172

ENGINEERING CONSULTANT:

PTR NO. :	PRC NO. :
TIN NO. :	DATE ISSUED :
PLACE ISSUED :	VALID UNTIL :

[illegible]

GRAPHIC SCALE :

DRAWING CONTENTS :

WINDOW SCHEDULE  
PART 2 AND ALUMINUM  
DOOR SCHEDULE

PROJECT NO. :		SHEET NO.
SCALE :	1:250 MTS.	P05-A-603
DRAWN BY :	J.D.V.	
DATE DRAWN :	2017/14/03	
CHECKED BY :		
FILE NAME :		